



**S.A. MIRO, INC.**  
**CONSULTING ENGINEERS**  
 4582 South Ulster Street Pkwy.  
 Suite 300 Denver, CO 80237  
 ph. 303 741 3737  
 fax 303 694 3134

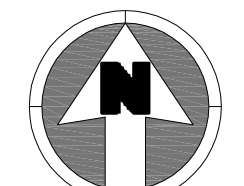

40 0 40  
 SCALE: 1" = 40'

**LEGEND**

	RIGHT OF WAY LINE
	CENTER LINE
	EXISTING MINOR CONTOURS
	EXISTING MAJOR CONTOURS
	PROPOSED MINOR CONTOURS
	PROPOSED MAJOR CONTOURS
	FLOW ARROW
	STORM SEWER LINE

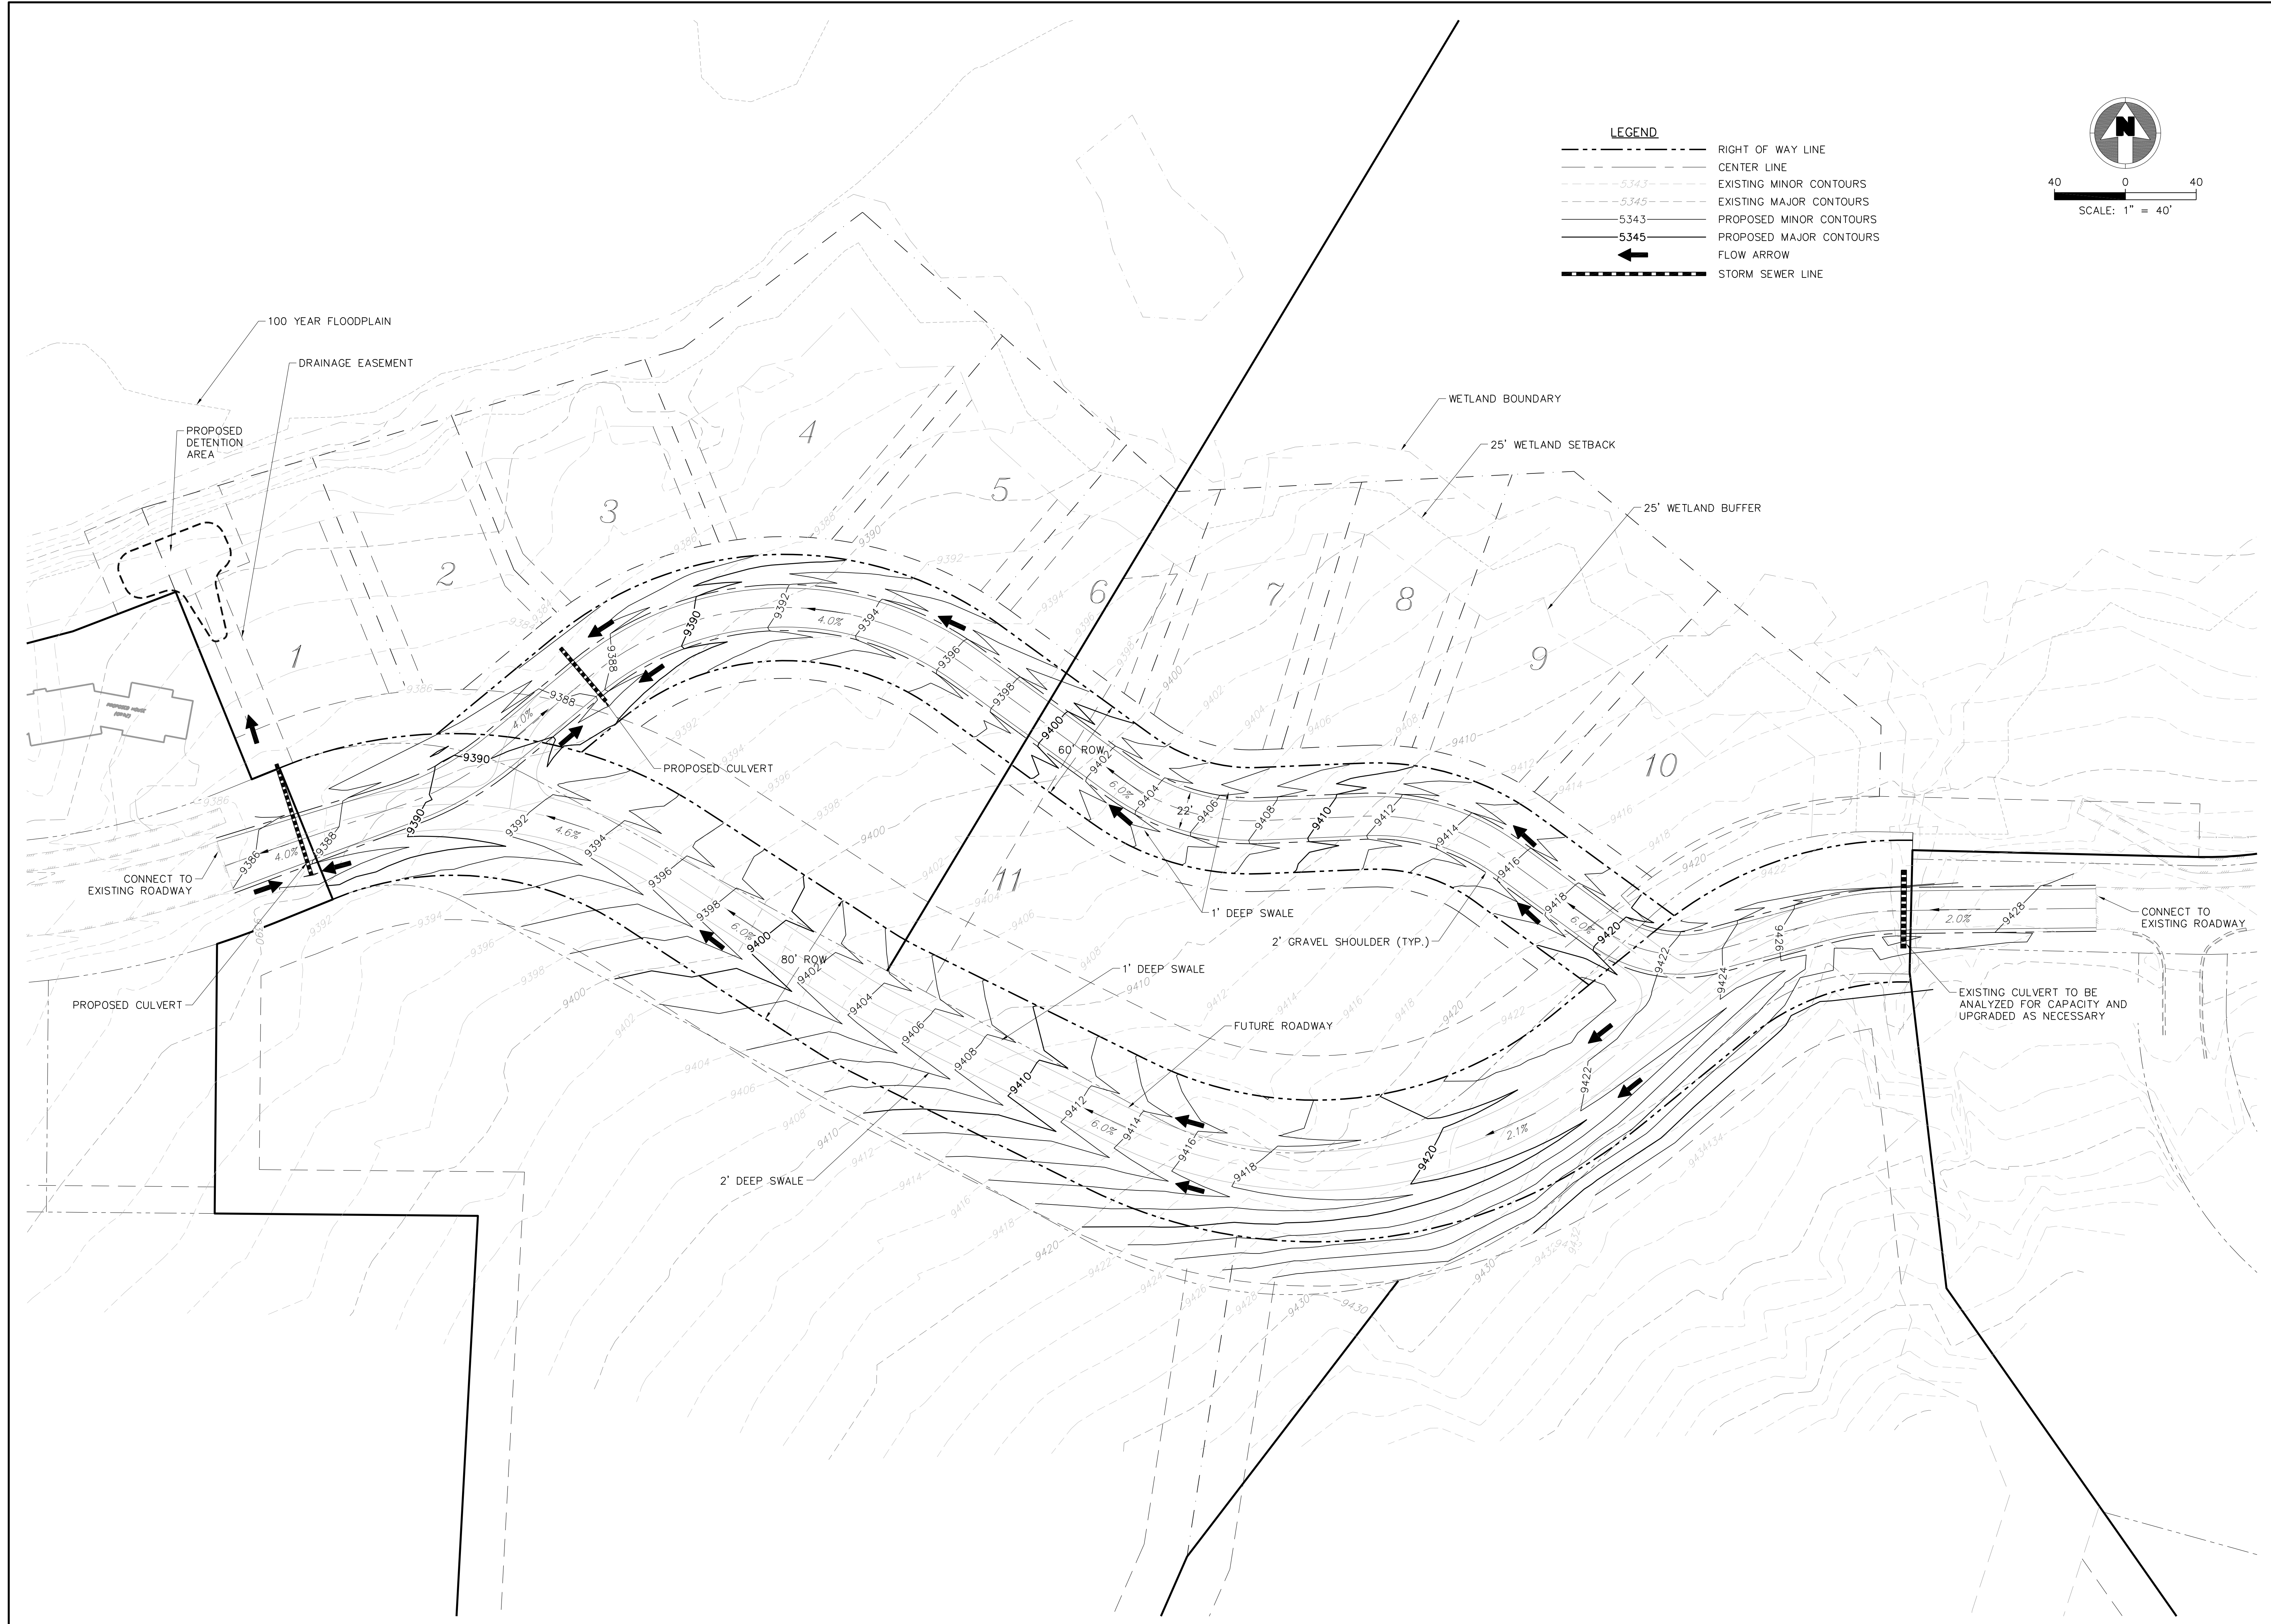

REV.	DESCRIPTION	DATE
1		
2		
3		
4		
5		
6		
7		
8		

CLIENT NAME: O'BRYAN PARTNERSHIP, INC.  
 PROJECT NAME: ALDERS SUBDIVISION  
 KEYSTONE, CO  
 DRAWING TITLE: GRADING PLAN  
 FILE PATH: K:\Jobs\10016 Alders\05 CAD\Plans and Details\C300-GRAD-PLAN.dwg C3.01

DESIGNED BY:	
DRAWN BY:	
CHECKED BY:	
DATE:	02/25/10
MIRO JOB NUMBER	CLIENT JOB NUMBER
10016	
DRAWING NUMBER:	
<b>C3.01</b>	
SHEET NO. _	